


LEGENDA / LEGEND:

- U.E.A  - Unitate exterioara AC
- Exterior AC unit

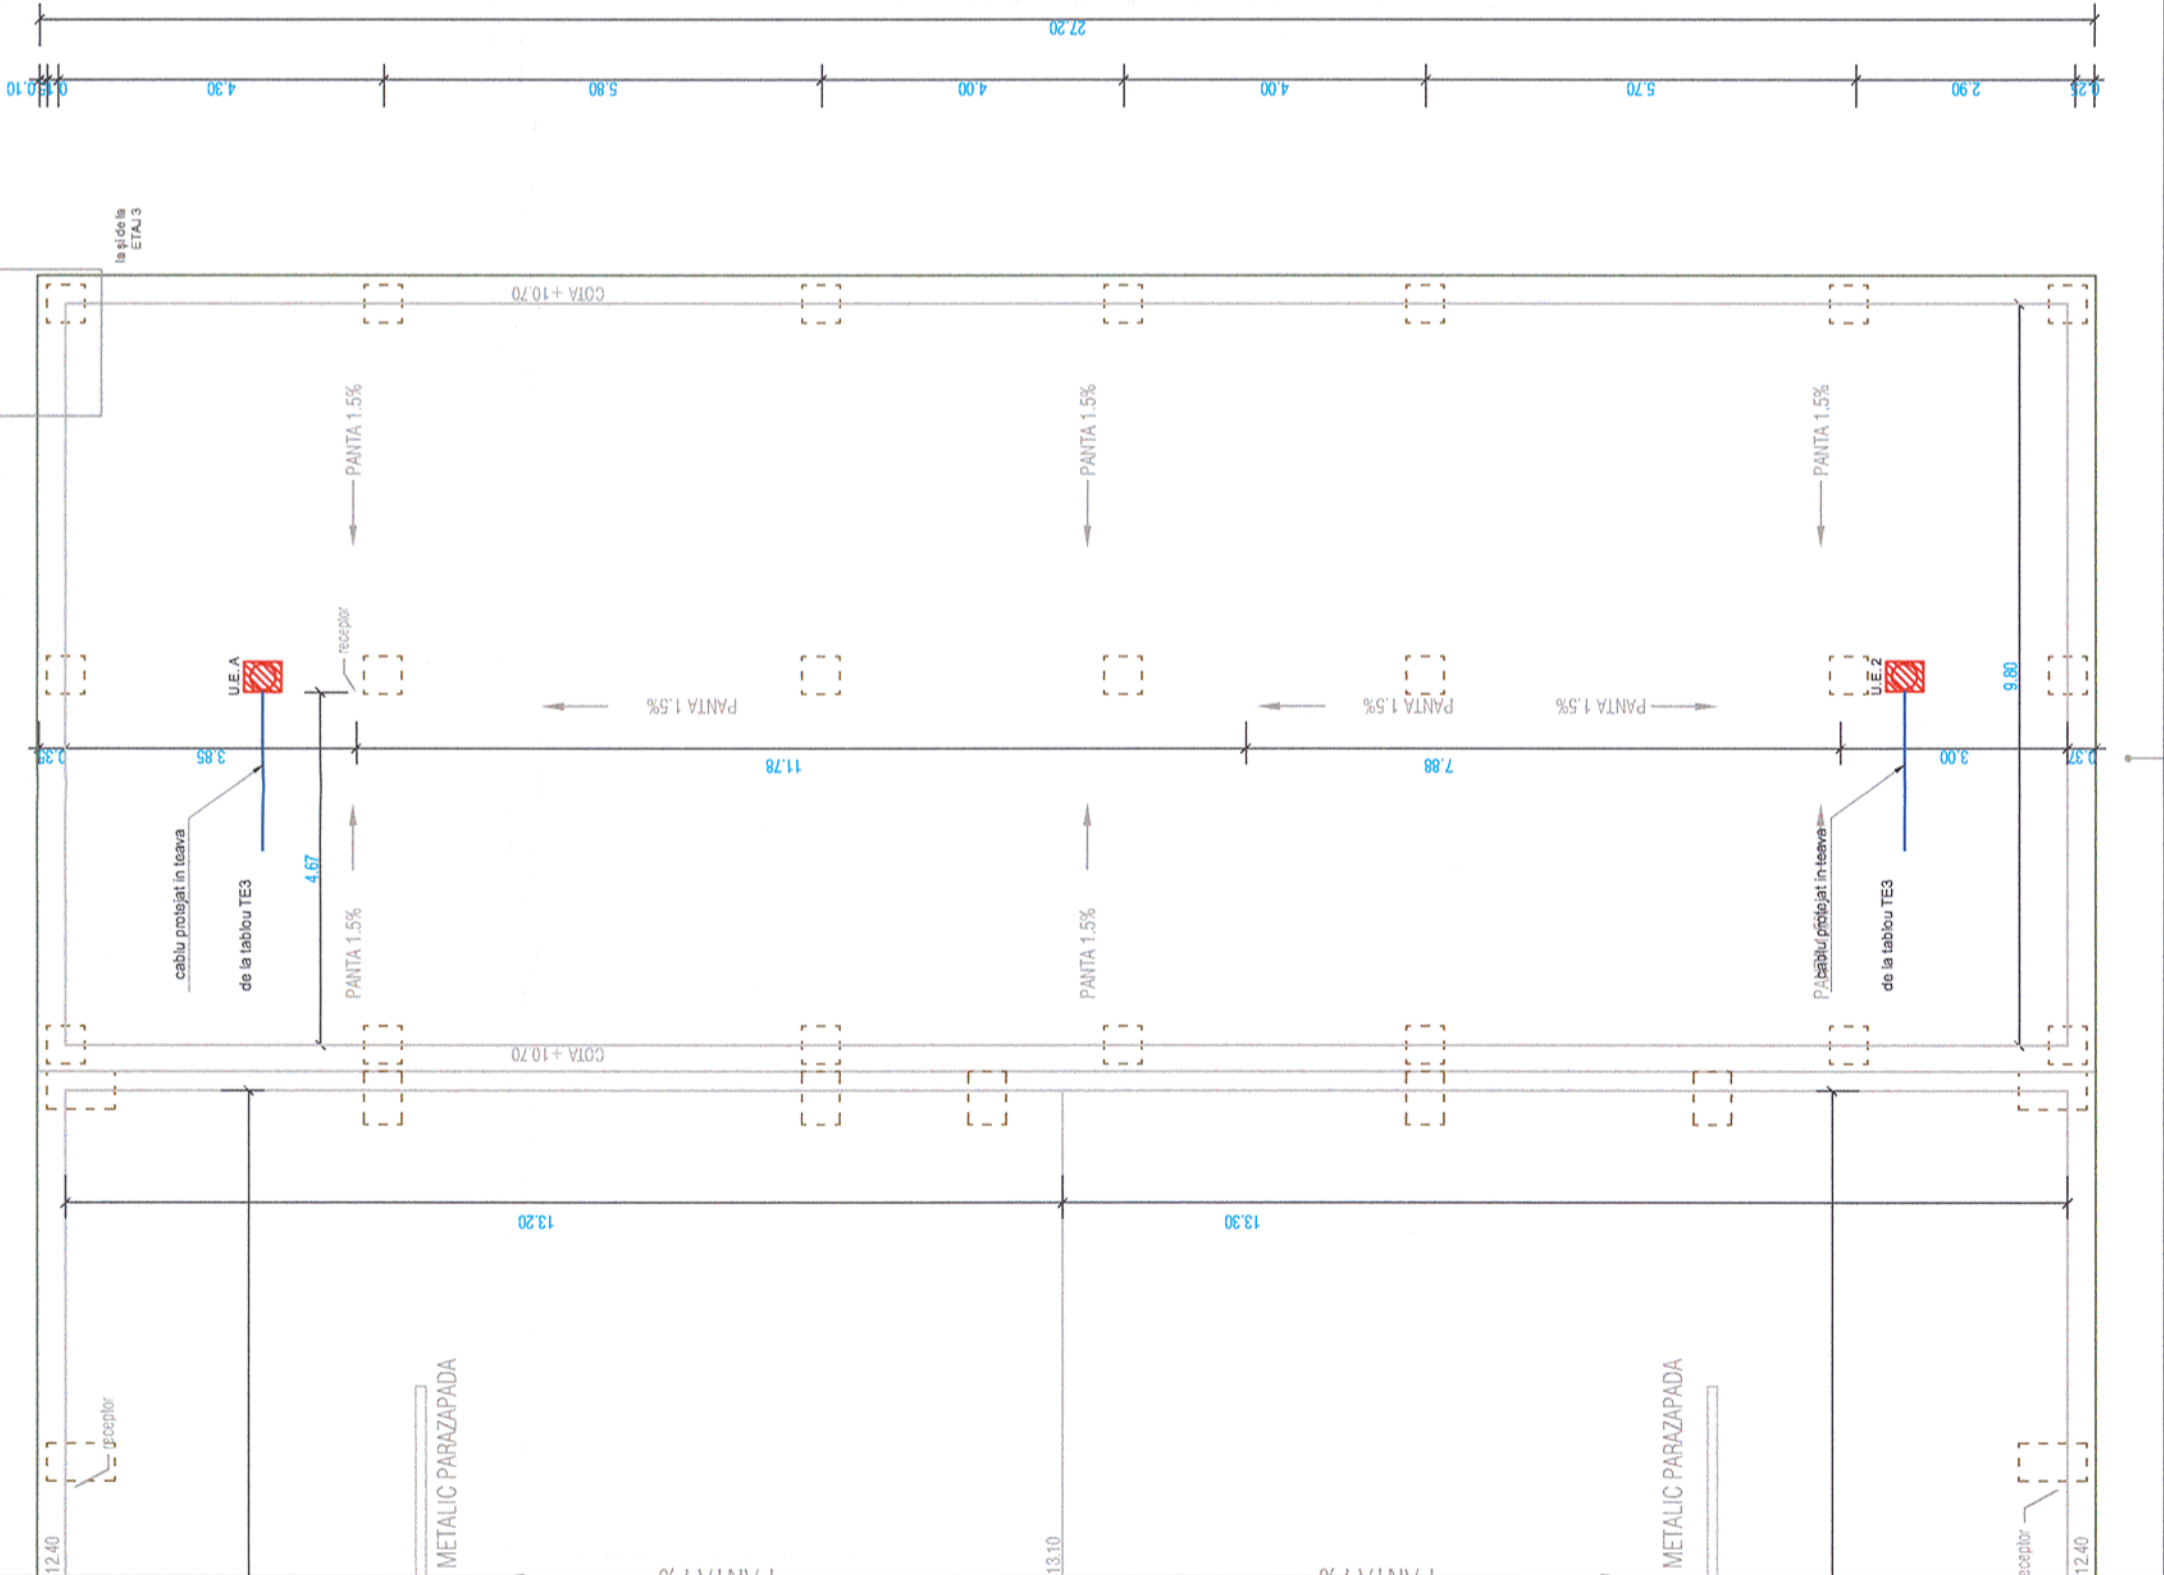



857/24.06.13

Verificator / Expert Checker / Expert	Cerinta Requirement	Semnatura Signature	Referat / Expertiza Report / Expertise
			
BENEFICIAR / BENEFICIARY :		COMPANIA NAȚIONALĂ DE CĂI FERATE "CFR" SA	



PROIECTANT / DESIGNER:		Data Date	Semnatura Signature
Aprobat Approved	Șef de echipă Team leader	01.2013	
Verificat Checked	Expert Cheie Key Expert	01.2013	



Subcontractant / Subcontractor		Data Date	
Aprobat Approved	Adjunct Șef de echipă Deputy Team leader	01.2013	
Proiectat Designed	Inginer Engineer	01.2013	
"Reabilitarea liniei c.f. Frontieră - Curtici - Simeria, parte componentă a coridorului IV Pan - European pentru circulația trenurilor cu viteză maximă de 160 km/h" Tronsonul 2 - A: Km 614 - Cap Y B Arzava		Proiect 9i 35311.1	
"Rehabilitation of the Railway Line Border - Curtici - Simeria, component Part of the IV Pan - European Corridor for the Trains Circulation with maximum speed of 160 km/h" Section 2 - A: Km 614 - End Y B Arzava		Faza / Phase: PTh+CS / TD+TS	

Denumire desen / Drawing name: Plan forță terasă - Hală mentenanță Radna Radna Maintenance hall - Power plan for terrace			
Scara / Scale 1:100	Revizia / Revision 1/05.2013	Cod desen / Drawing Code PT.2A.03.06.IE.07.012	Nr / No 12/31