


Plan terasa

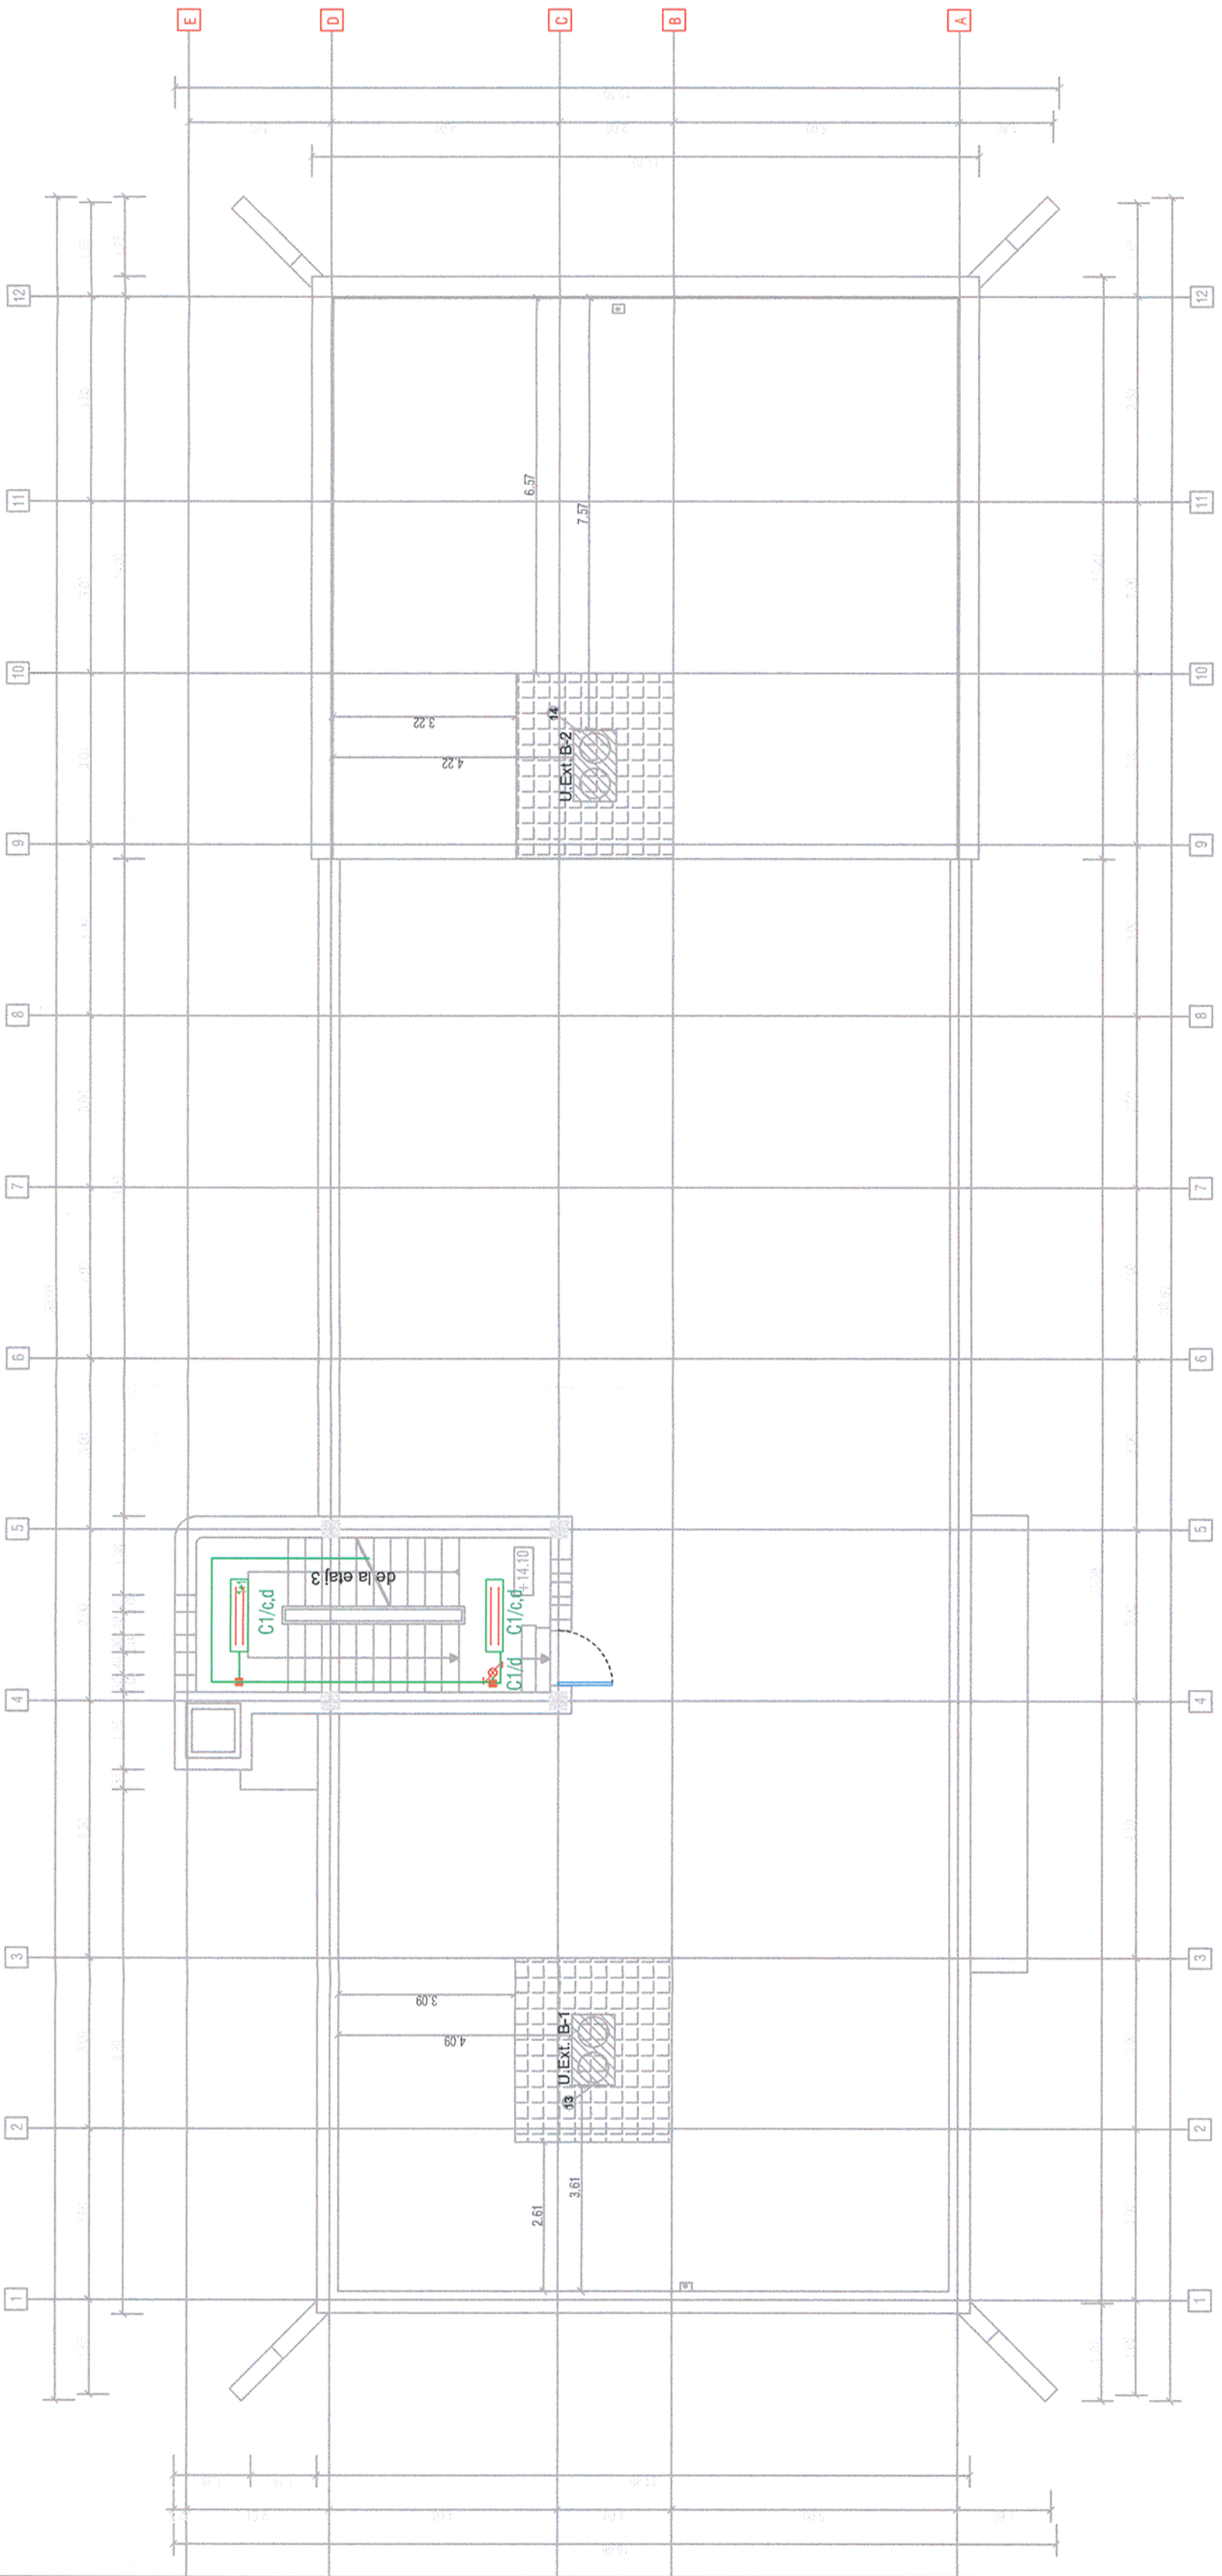

LEGENDA/LEGEND:

- Corp de iluminat echipat cu lămpi tubulare fluorescente 2x36W, 1 lampa alimentata normal, 1 lampa alimentata prin kit back-up 230V,50Hz, clasă I, IP40, montat aparent
- Fluorescent luminaire, 2x36W, 230V,50Hz, class I, IP 40, with back-up;
- Corp de iluminat echipat cu lămpi tubulare fluorescente 2x36W, 230V,50Hz, clasă I, IP40, montat aparent
- Fluorescent luminaire, 2x36W, 230V,50Hz, class I, IP 40;
- Comutator capat, 250V,10A
- Switch for stairs, 250V,10A
- Circuit iluminat
- Lighting circuit

Verificator / Expert Checker / Expert		Cerința Requirement		Semnătura Signature	
MINISTERUL TRANSPORTURILOR		BENEFICIAR / BENEFICIARY : 		COMPANIA NAȚIONALĂ DE CĂI FERATE "CFR" SA	
PROIECTANT / DESIGNER: 			Data Date		Semnătura Signature
Aprobat Approved	Șef de echipă Team leader	C. Teodorescu	01.2013		
Verificat Checked	Expert Cheie Key Expert	D.A. Stănescu	01.2013		
Subcontractant / Subcontractor 					
Aprobat Approved	Adjunct Șef de echipă Deputy Team leader	A.M. Baicu	01.2013		
Proiectat Designed	Inginer Engineer	M. Ciocirlan	01.2013		
"Reabilitarea liniei c.f. Frontieră - Simeria, parte componentă a coridorului IV Pan - European pentru circulația trenurilor cu viteză maximă de 160 km/h" Tronsoanel 3: Gurasada - Simeria "Rehabilitation of the Railway Line Border - Curtici - Simeria, component Part of the IV Pan - European Corridor for the Trains Circulation with maximum speed of 160 km/h" Section 3: Gurasada - Simeria					
Denumire desen / Drawing name: Iluminat plan terasă - Regulator circulație Deva Deva Traffic Controller Building - Lighting plan for terrace					
Scara / Scale 1:100		Revizia / Revision 1/05.2013		Cod desen / Drawing Code PT.03.03.26.IE.06.010	Nr / No 10/24