


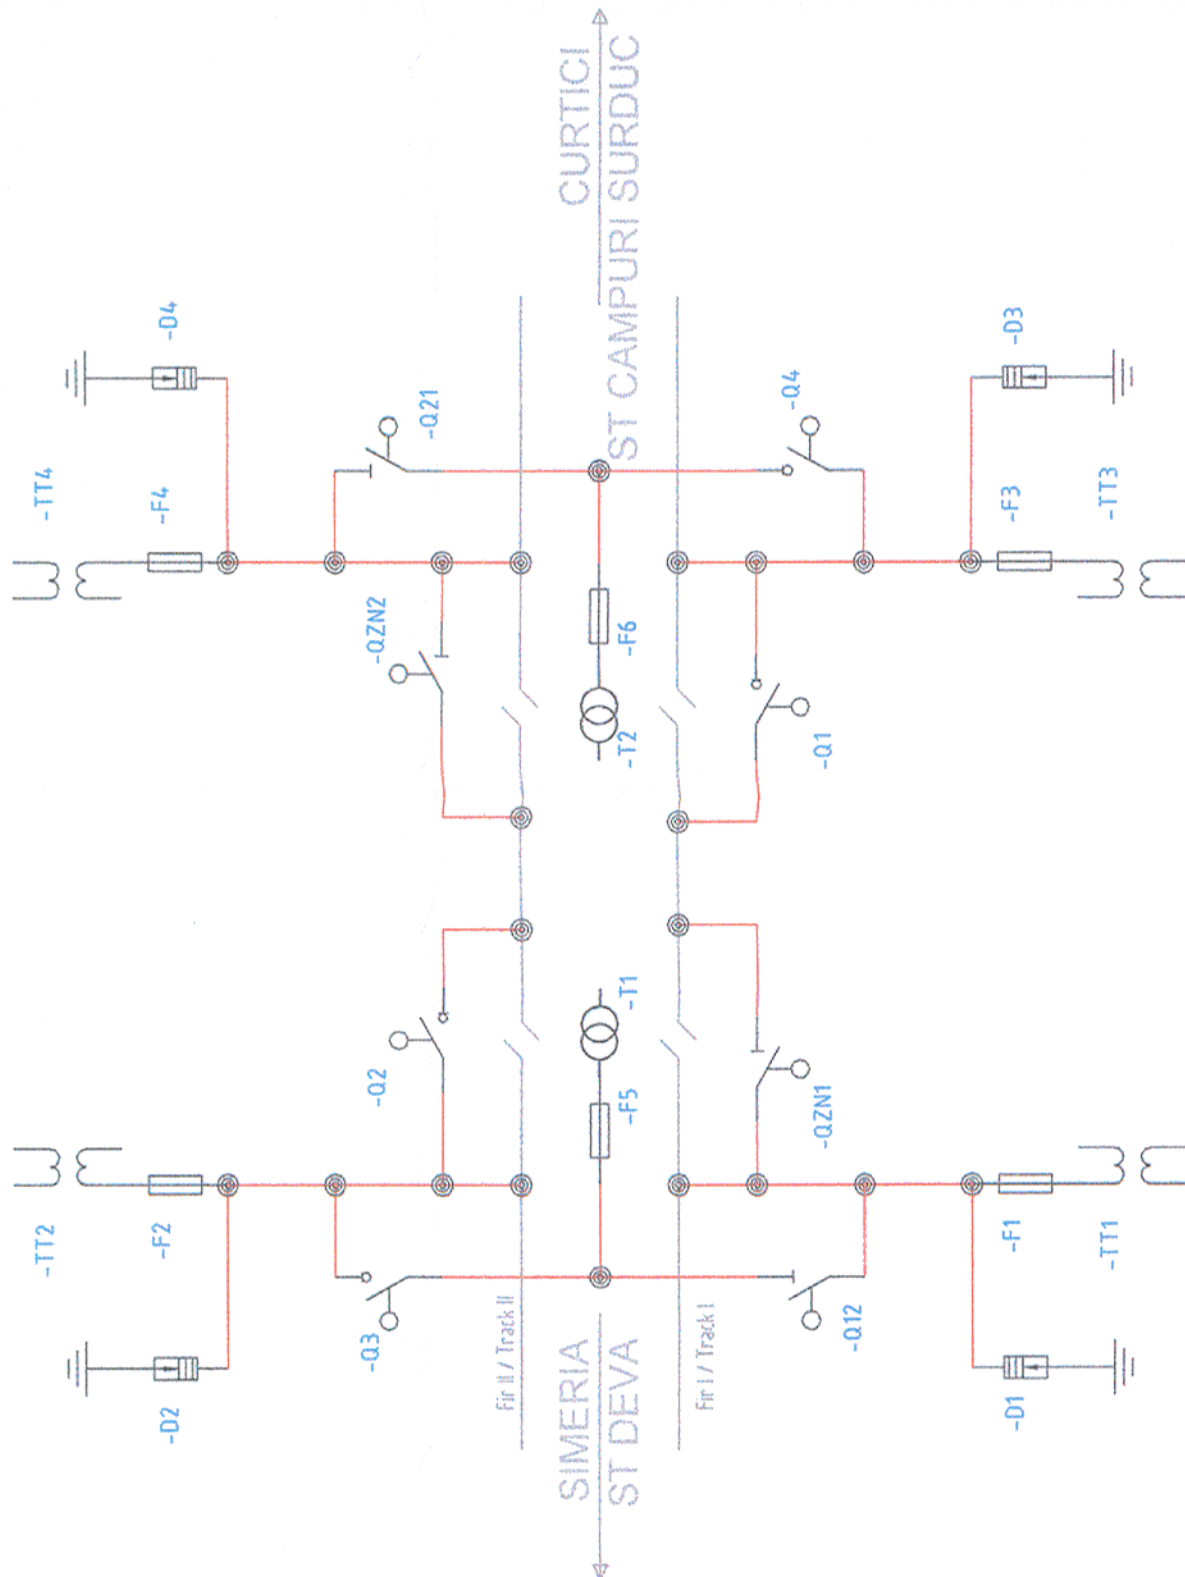

LEGENDA / LEGEND

-Qx	Separator de sarcina
-QZNx	Switch (Load breaker)
-Q12x	Separator actionat electric
-Q12x	Motor operated disconnect
-Q12x	Separator actionat manual
-Q12x	Manual operated disconnect
-Dx	Descarcator cu ZnO
-Fx	ZnO surge arrester
-TTx	Siguranță fuzibilă de înaltă tensiune
-TTx	High voltage fuse
-Tx	Transformator de tensiune
-Tx	Voltage transformer
-Tx	Transformator de putere
-Tx	Power transformer

Verificator / Expert Checker / Expert		Cerinta Requirement	Semnatura Signature	Referat / Expertiza Report / Expertise		
European Investment Bank			MINISTERUL TRANSPORTURILOR			
BENEFICIAR / BENEFICIARY :						
COMPANIA NAȚIONALĂ DE CĂI FERATE "CFR" SA						
PROIECTANT / DESIGNER:						
PÖYRY						
Aprobat Approved	Sef de echipa Team leader	C. Teodorescu	01.2013	Semnatura Signature		
Verificat Checked	Expert Cheie Key Expert	/ D. Stanescu	01.2013			
Subcontractant / Subcontractor						
VIOTOP						
Aprobat Approved	Adjunct Sef de echipa Deputy Team leader	A.M. Baicu	01.2013			
Proiectat Designed	Inginer Engineer	M. Golea	01.2013			
"Reabilitarea liniei c.f. Frontieră - Curtici - Simeria, parte componentă a coridorului IV Pan - European pentru circulația trenurilor cu viteză maximă de 160 km/h"			Project 9i 35311.1			
"Rehabilitation of the Railway Line Border - Curtici - Simeria, component Part of the IV Pan - European Corridor for the Trains Circulation with maximum speed of 160 km/h"			Faza / Phase: PTH+CS / TD+TS			
Section 3 : Gurasada - Simeria						
Denumire desen / Drawing name:						
PS BRANISCA - Schema monofilara / Single line diagram						
Scara / Scale 1:1000	Revizia / Revision 1/16.05.2013	Cod desen / Drawing Code PT.03.05.23.EA.001	Nr / No 01/05			