


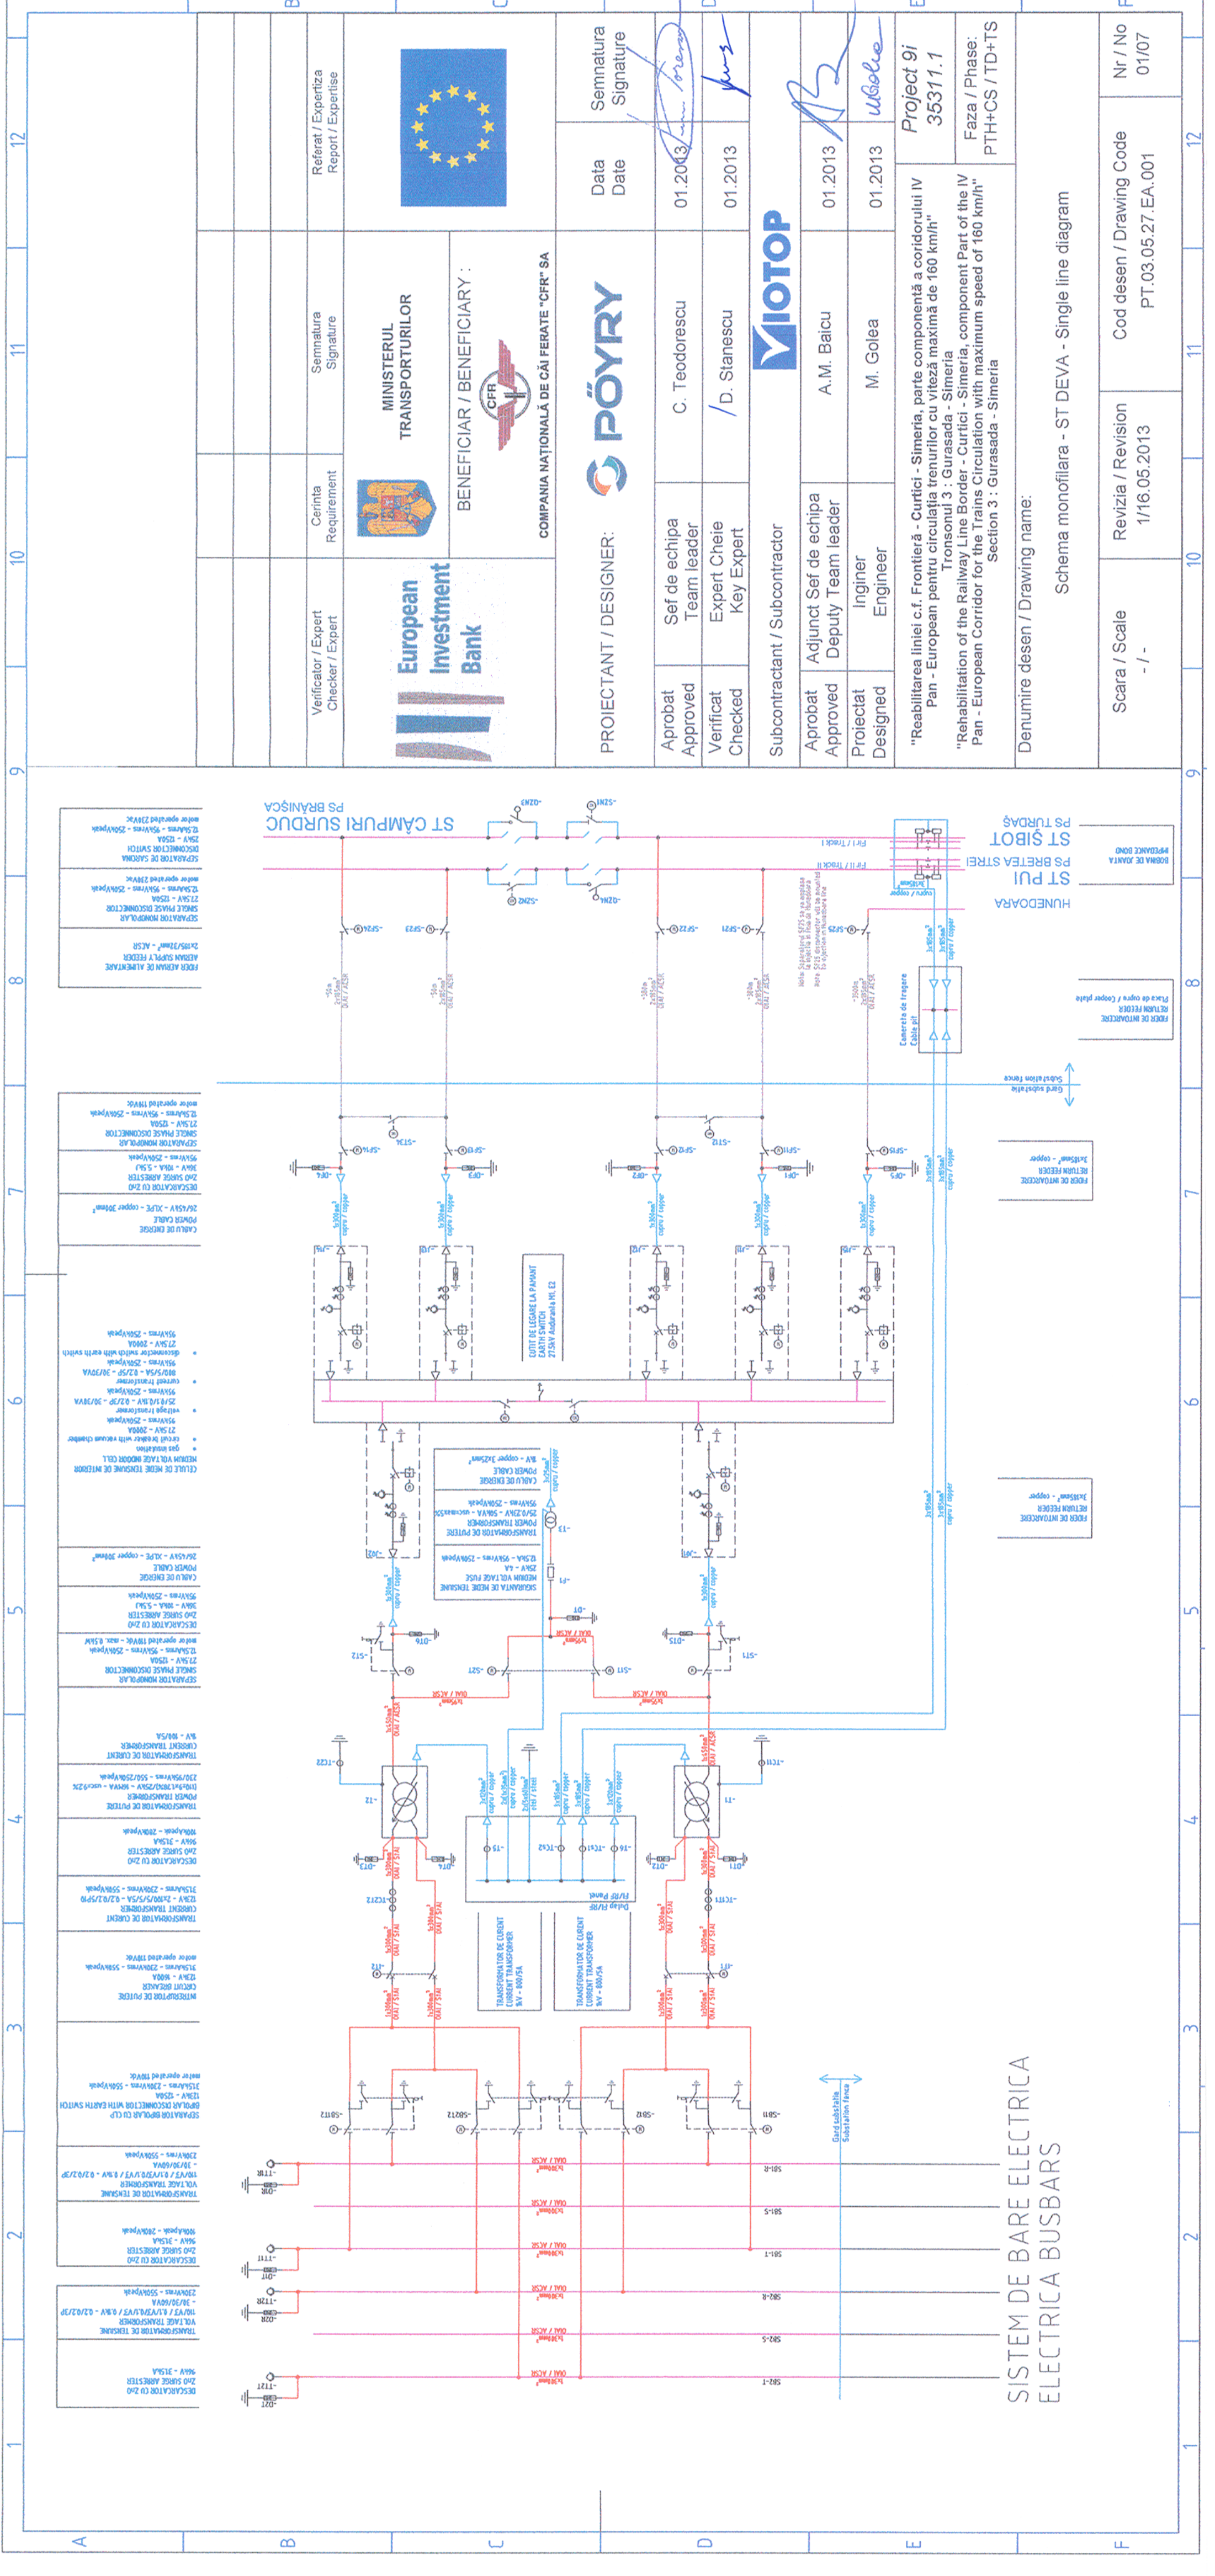

Verificator / Expert Checker / Expert		Cerinta Requirement	Semnatura Signature	Referat / Expertiza Report / Expertise
			MINISTERUL TRANSPORTURILOR	
		BENEFICIAR / BENEFICIARY : COMPANIA NAȚIONALĂ DE CĂI FERATE "CFR" SA		
PROIECTANT / DESIGNER: 				
Aprobat Approved	Sef de echipa Team leader	C. Teodorescu		
Verificat Checked	Expert Cheie Key Expert	/ D. Stanescu		
Subcontractant / Subcontractor 				
Aprobat Approved	Adjunct Sef de echipa Deputy Team leader	A.M. Baicu		
Proiectat Designed	Inginer Engineer	M. Golea		
"Reabilitarea liniei c.f. Frontieră - Curtici - Simeria, parte componentă a coridorului IV Pan - European pentru circulația trenurilor cu viteză maximă de 160 km/h" Tronsonul 3 : Gurasada - Simeria				
"Rehabilitation of the Railway Line Border - Curtici - Simeria, component Part of the IV Pan - European Corridor for the Trains Circulation with maximum speed of 160 km/h" Section 3 : Gurasada - Simeria				
Denumire desen / Drawing name: Schema monofilara - ST DEVA - Single line diagram				
Scara / Scale - / -	Revizia / Revision 1/16.05.2013	Cod desen / Drawing Code PT.03.05.27.EA.001		Nr / No 01/07